


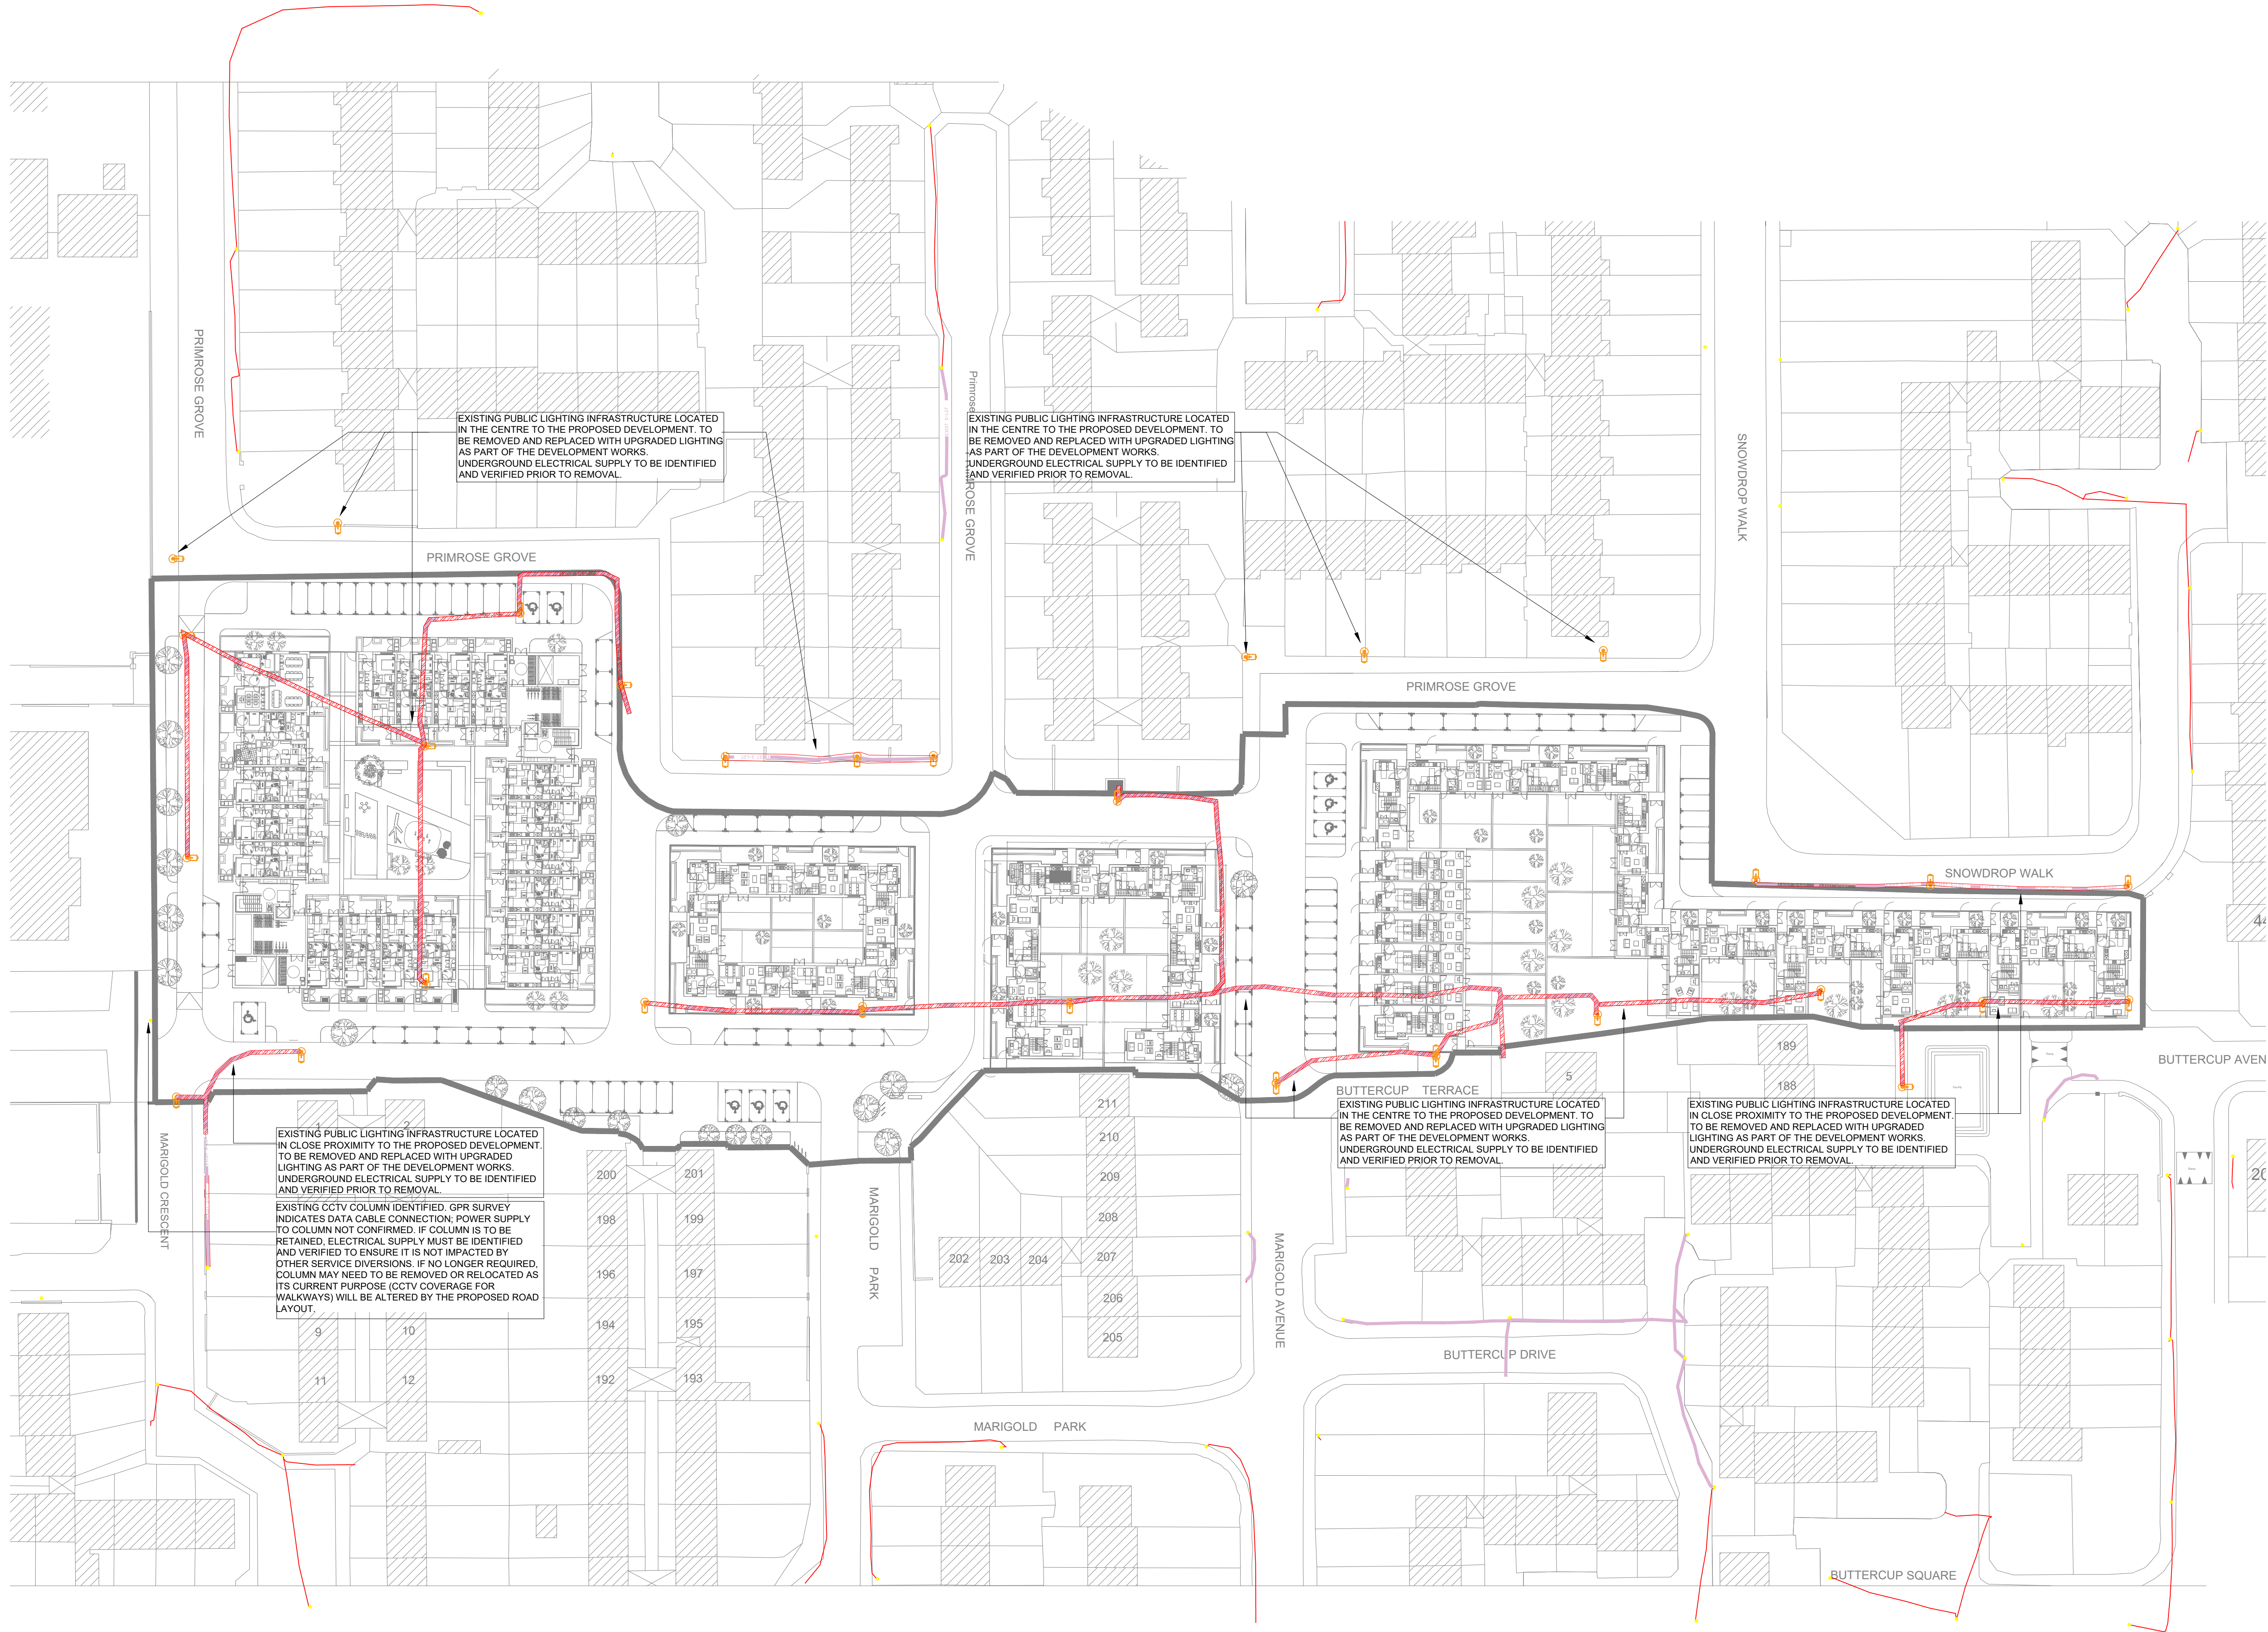

ELECTRICAL LEGEND	
	EXISTING UNDERGROUND STREET/SITE LIGHTING CABLE ROUTE (SUBJECT TO IDENTIFICATION ON SITE)
	EXISTING OVERHEAD STREET/SITE LIGHTING CABLE ROUTE (SUBJECT TO IDENTIFICATION ON SITE)
	DENOTES 50mm DIA RED ESBN DUCT WITH 10mm NYLON ROPE DRAW WIRE SHALL BE INSTALLED FROM ESBN MINI-PILLAR TO PL MICRO PILLAR
	PROPOSED PUBLIC LIGHTING DUCTING ROUTE. DUCTS SHALL BE uPVC COMPLYING WITH BS3506 CLASS B OR HIGH DENSITY POLYTHENE PIPE TO LS135 CLASS B. MINIMUM SIZE 100mm WITH 100mm SPARE DUCTS DEPLOYED AT ROAD CROSSINGS. DUCTING TO BE STAMPED 'PUBLIC LIGHTING' OR 'STREET LIGHTING' AT 1m INTERVALS.
	PROPOSED (800x800) CONCRETE DRAW PIT / INSPECTION CHAMBER.
	EXISTING ESBN MINI-PILLARS
	PROPOSED ESBN MINI-PILLARS WITH VC2 VAULT INSTALLED DIRECTLY IN FRONT
	PROPOSED ESBN MICRO-PILLARS FOR UNMETERED SUPPLIES PUBLIC LIGHTING
	DENOTES 6 METRE COLUMN MOUNTED PUBLIC LIGHTING LUMINAIRE
	DENOTES COLUMN 6 METRE MOUNTED PUBLIC LIGHTING AMENITY LUMINAIRE.
	DENOTES EXISTING STREET LIGHTING LUMINAIRE & 6m COLUMN.

P05	UPDATED SITE PLAN - ISSUED FOR PLANNING	EK	GF	22.07.2026
P04	ISSUED FOR PLANNING	EK	GF	14.07.2026
P03	ISSUED FOR PLANNING	EK	GF	17.04.2026
P02	ISSUED FOR PLANNING	EK	GF	18.03.2026
P01	ISSUED FOR PLANNING	EK	GF	16.12.2025

REV	DESCRIPTION	DRN	CHK	DATE
-----	-------------	-----	-----	------

ISSUE PLANNING STAGE

simple mckillop

NATURALLY INNOVATIVE CONSULTING ENGINEERS

Belfast +44 (0)28 90331700
Castleblayney +353 (0)42 9749570

Registered www.semplemckillop.com admin@semplemckillop.com

PROJECT TITLE
HOUSING DEVELOPMENT, DARNDALE, CO. DUBLIN

DRAWING TITLE
SITE SERVICES - EXISTING LIGHTING
ARRANGEMENT

DRAWING REFERENCE	DRN	SCALE
3223-SMK-XX-ZZ-DR-E-6002	AS	A1 1:500