


Section E-E, C0 Stair Section



1:100

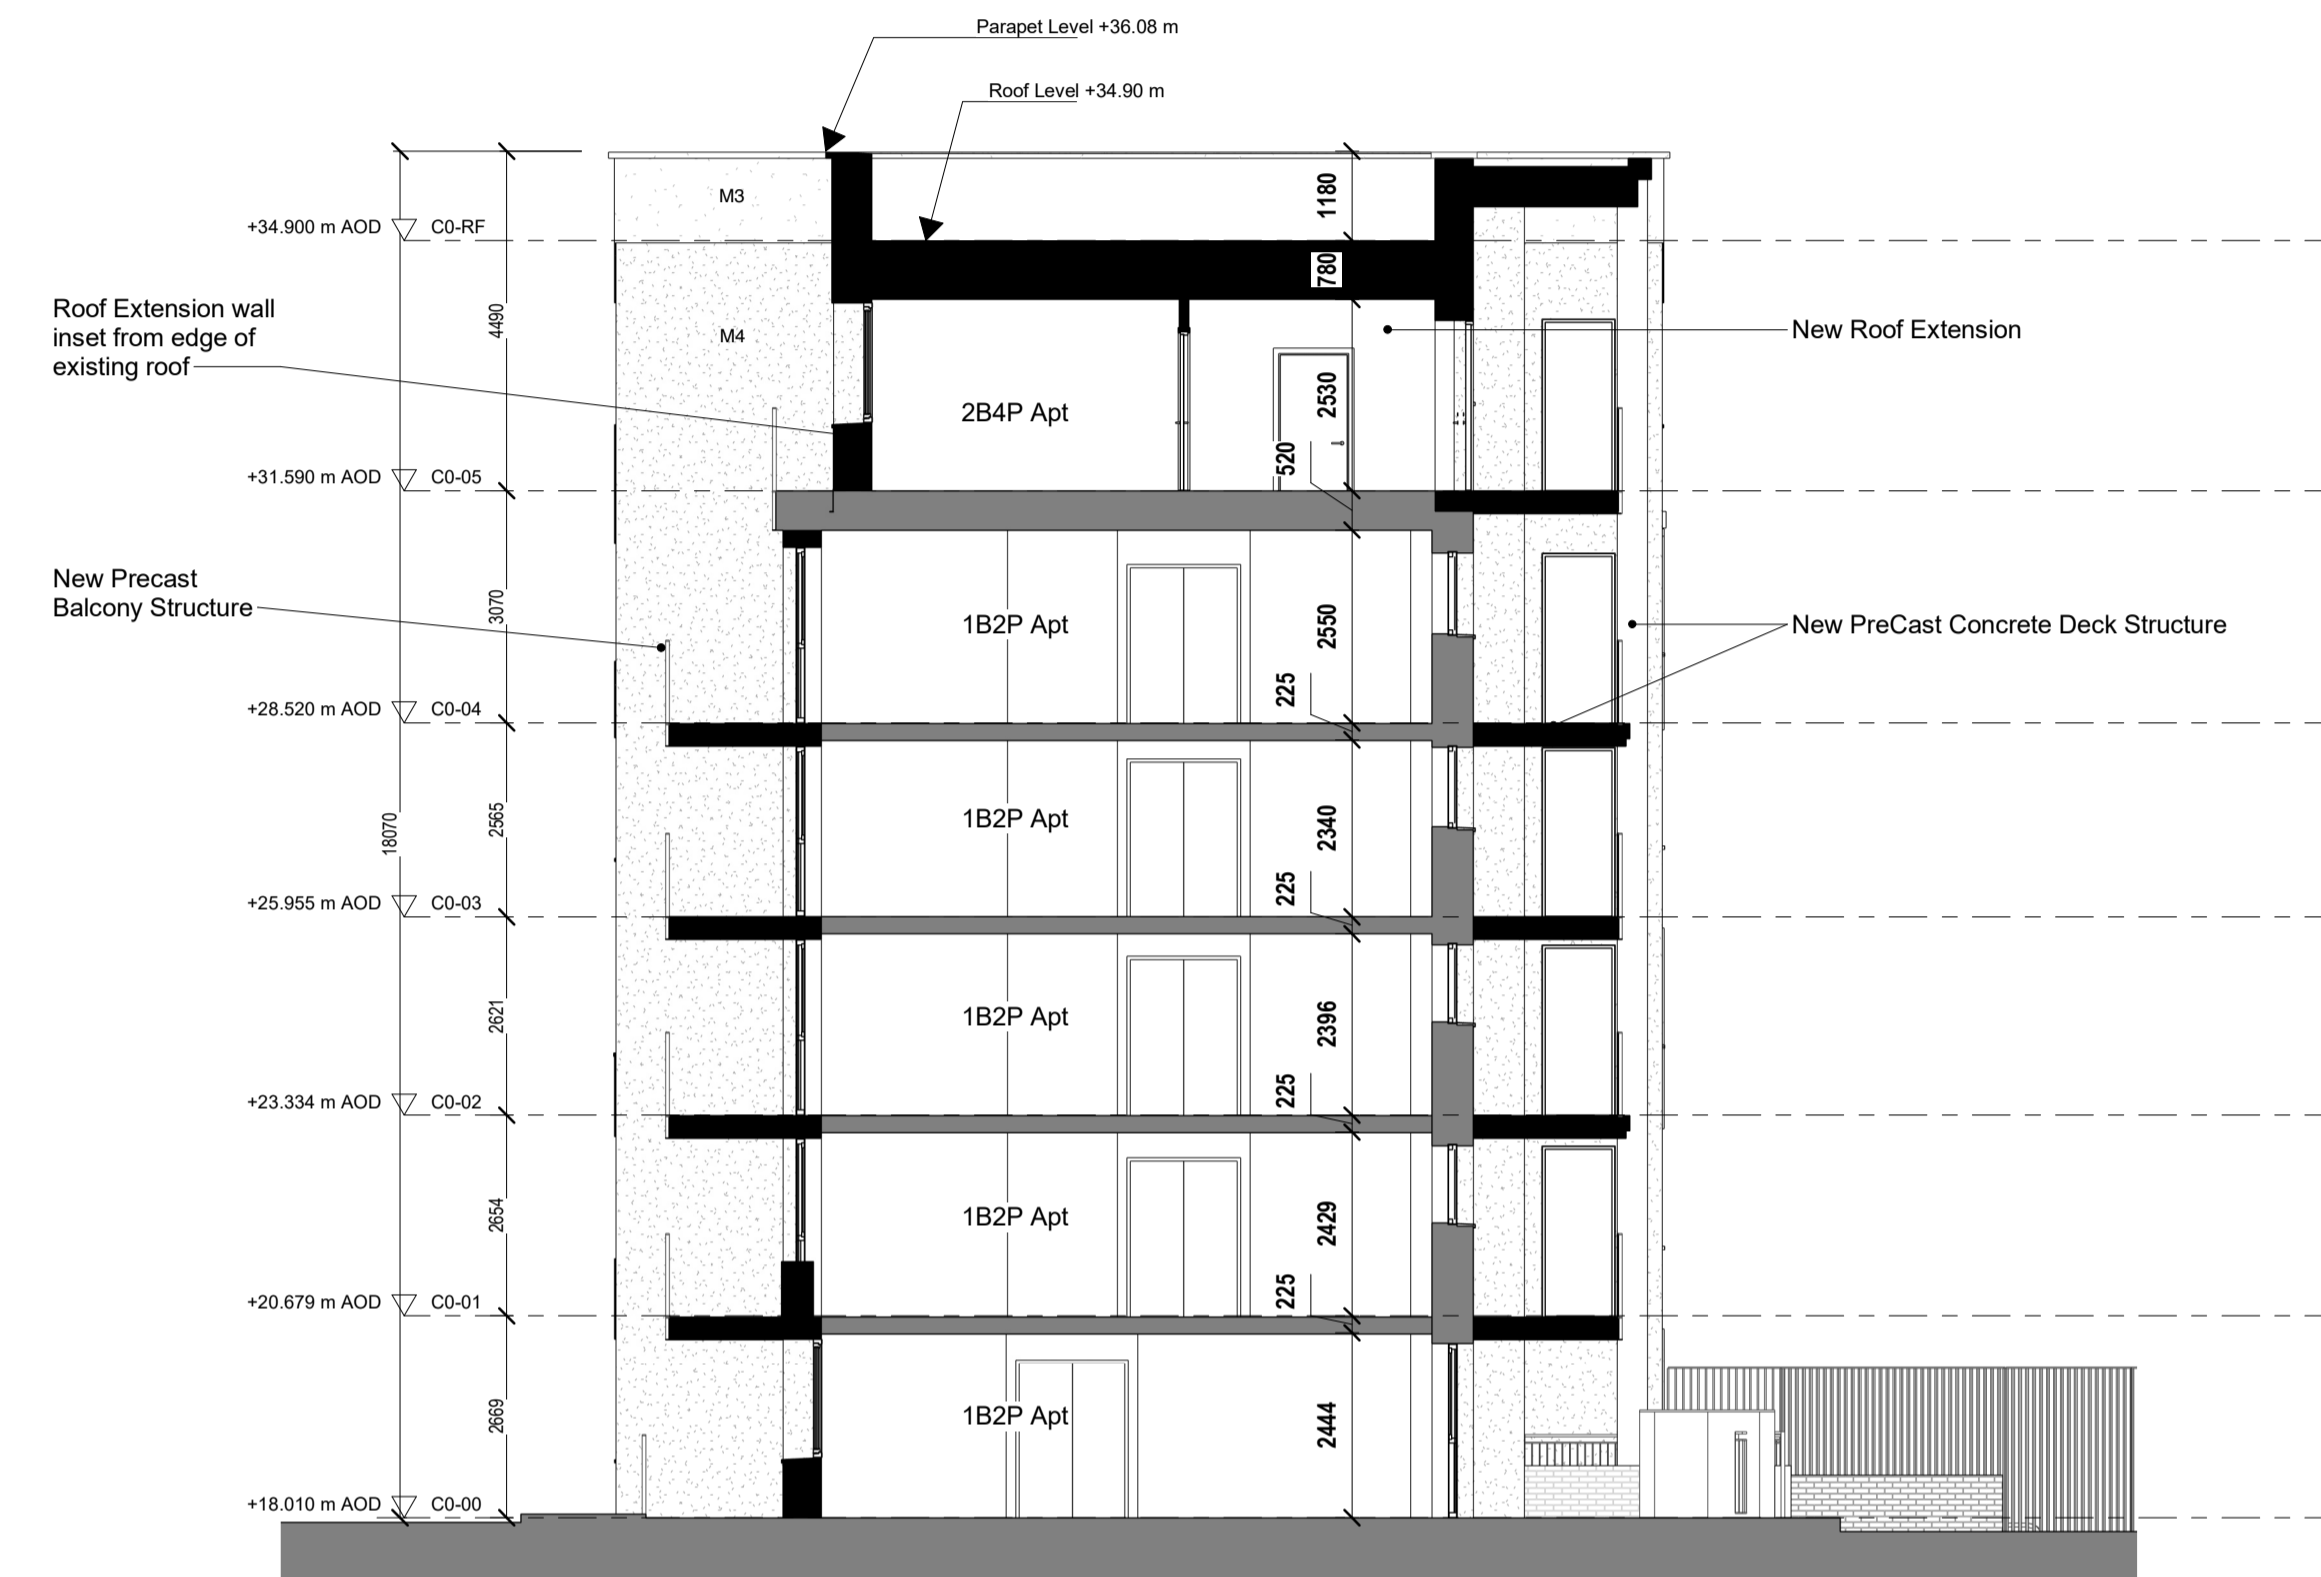

Section F-F, C0 Typical Section

1:100

Fabric Retained, Repaired & Insulated  
 New Construction

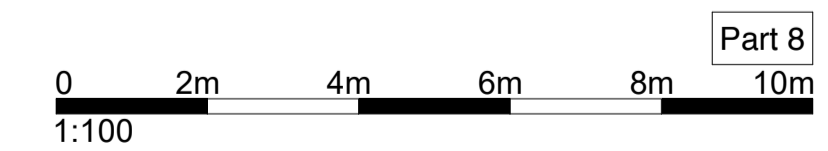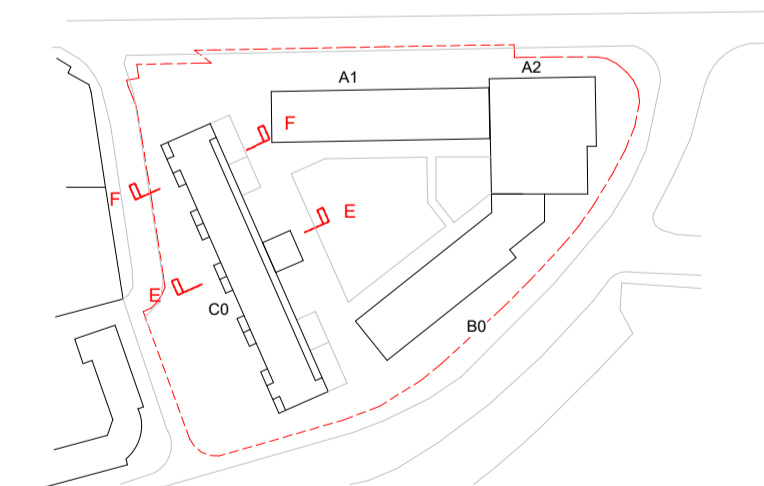

Part 8

Revision	Date	Description	Issued	Checked
P1	11/12/2025	Issued for Planning	PDF	DCC



**Notes**  
 For coordination purposes only. Do not scale drawings.  
 Errors to be reported to the Architect. To be read in conjunction with all relevant consultants information.  
 All levels shown are indicative of proposed internal floor levels, and are above Ordnance Datum.

**Copyright**  
 Copyright Metropolitan Workshop LLP. No implied license exists. This drawing should not be used to calculate areas for the purpose of valuation.  
 This drawing was prepared in part, based on survey information provided by others. Whilst this information is believed to be reliable, Metropolitan Workshop assumes no responsibility for the accuracy of this information or any errors or omissions that may have been incorporated into it as a result of incorrect information provided by others.

KEY:	
1	PV Panels
2	Lift Overrun
3	AOV Roof Hatch
4	Roof Access Hatch
5	Green/Blue Roof
9	External Bike store
11	Brick garden w/ railing
12	Brick pier with panel doors (ESB)
17	PPC Metal Entrance Canopy
M1.1	Dark Red Brickwork - stretcher bond Colour TBC
M1.2	Light Red Brickwork - stretched bond Colour TBC
M2	Alternating Brickwork - stretched bond Colour TBC
M3	Smooth Render - White Tone
M4	Rough Render - White Tone
M7	Fixed Glazed Panel
M8	Aluminium/timber composite window frames, PPC sills
M9	Aluminium/timber composite glazed patio frames
M10	Solid Panel Door with glazed side panel
M11	Solid Panel w. faulight above
M12	Solid Panel Door
M13	PPC Metal Rainwater goods, Colour TBC
M14	Precast Concrete Parapet Capping
M15	Precast Concrete Entrance Canopy
M18	Precast Concrete Access Deck Structure
M19	Concrete columns overlaid in Brick
M20	PPC Metal Balcony System, Colour TBC
M21	PPC Metal Deck Railing, solid panel backed, Colour TBC
M22	PPC Metal Courtyard Entrance Gate and Railing, 3400mm
M23	PPC Aluminium Curtain Walling, Colour TBC
M24	Louvered screen mechanical plant
M27	Concrete column
M28	Solid Panel service door w. louvered ventilation above
M30	Solid Panel service door

**Metropolitan Workshop**  
 Tower 1, Fumbally Lane, Dublin  
 D08 FX95  
 00 353 (0)1 531 4889  
 www.metwork.ie

Project:	School Street
Client:	Dublin City Council
Location:	School Street, The Liberties, Dublin 8
Title:	C0 Proposed Section
Date:	11/12/2025
Scale:	As indicated @ A1
Drawing Number:	2303