

SURFACE WATER DRAINAGE PIPE TABLE

SURFACE WATER DRAINAGE STRUCTURES TABLE

NOTES

1. DO NOT SCALE. ALL DIMENSIONS ON DRAWINGS ARE IN METERS UNLESS NOTED OTHERWISE. USE FIGURED DIMENSIONS ONLY.
2. THIS DRAWING IS TO BE READ IN CONJUNCTION WITH ALL OTHER WORKS REQUIREMENTS
3. CO-ORDINATES ARE TO IRISH TRANSVERSE MERCATOR (ITM)
4. LOCATION OF EXISTING UTILITIES TO BE CONFIRMED WITH GPR SURVEY.

LEGEND

SITE BOUNDARY

LEGEND (SURFACE WATER SEWER NETWORK)

EXISTING SURFACE WATER SEWER

EXISTING SURFACE WATER MANHOLE



PROPOSED SURFACE WATER SEWER

PROPOSED SURFACE WATER MANHOLE

PROPOSED SURFACE WATER
RECTANGULAR MANHOLE

PROPOSED FILTER DRAIN


- NOTE:
1. REFER TO STORMWATER MANAGEMENT PLAN REPORT FOR FURTHER DETAILS WITH REGARD TO SURFACE WATER DESIGN , SUDS AND ATTENUATION.
 2. REFER TO DRAWING 232168-PUNCH-XX-XX-DR-C-0151 FOR SUDS LAYOUT.
 3. REFER TO DRAWING 232168-PUNCH-XX-XX-DR-C-0503 FOR SUDS DETAILS.

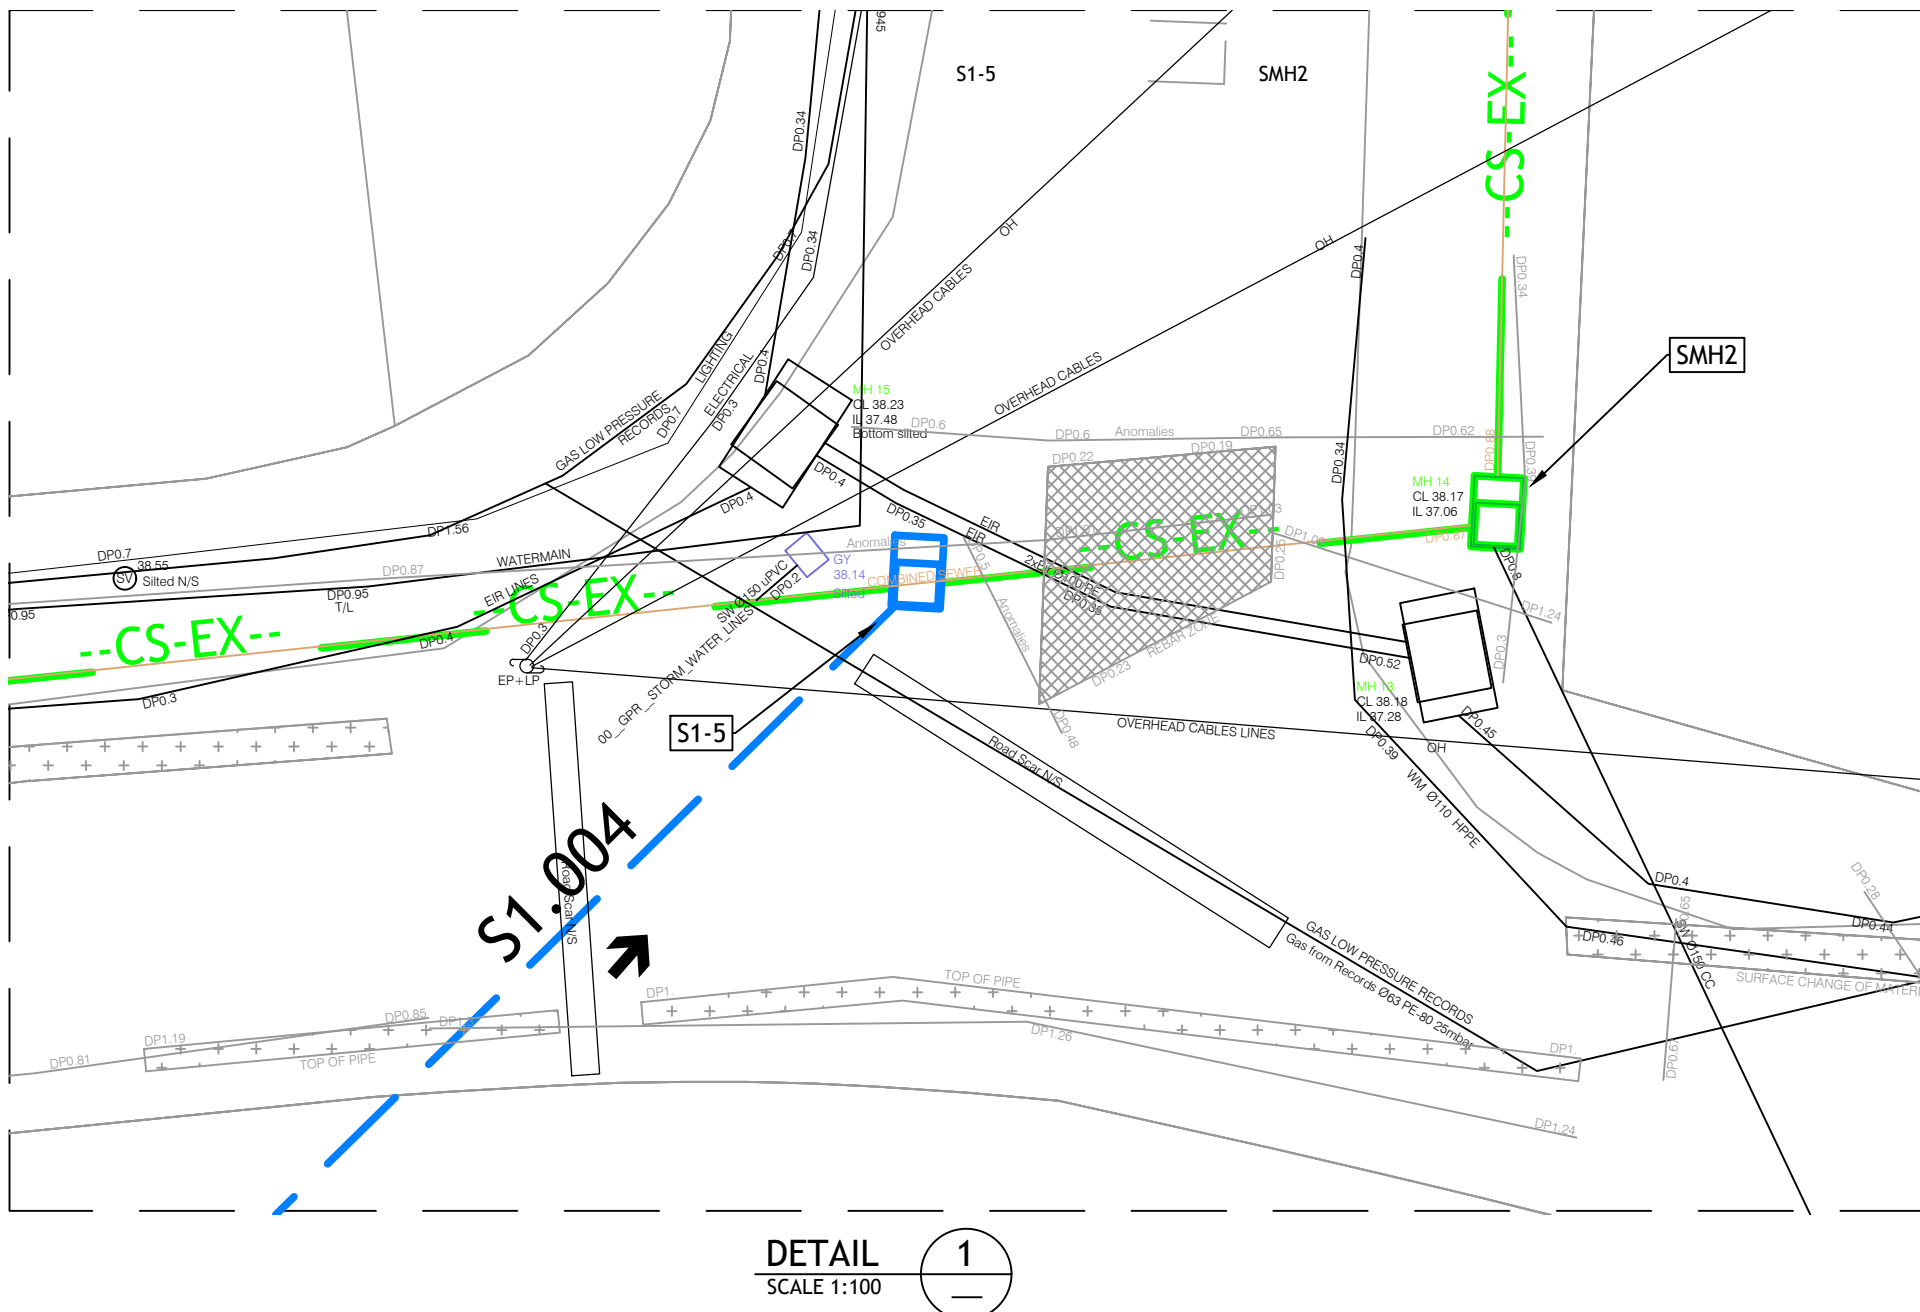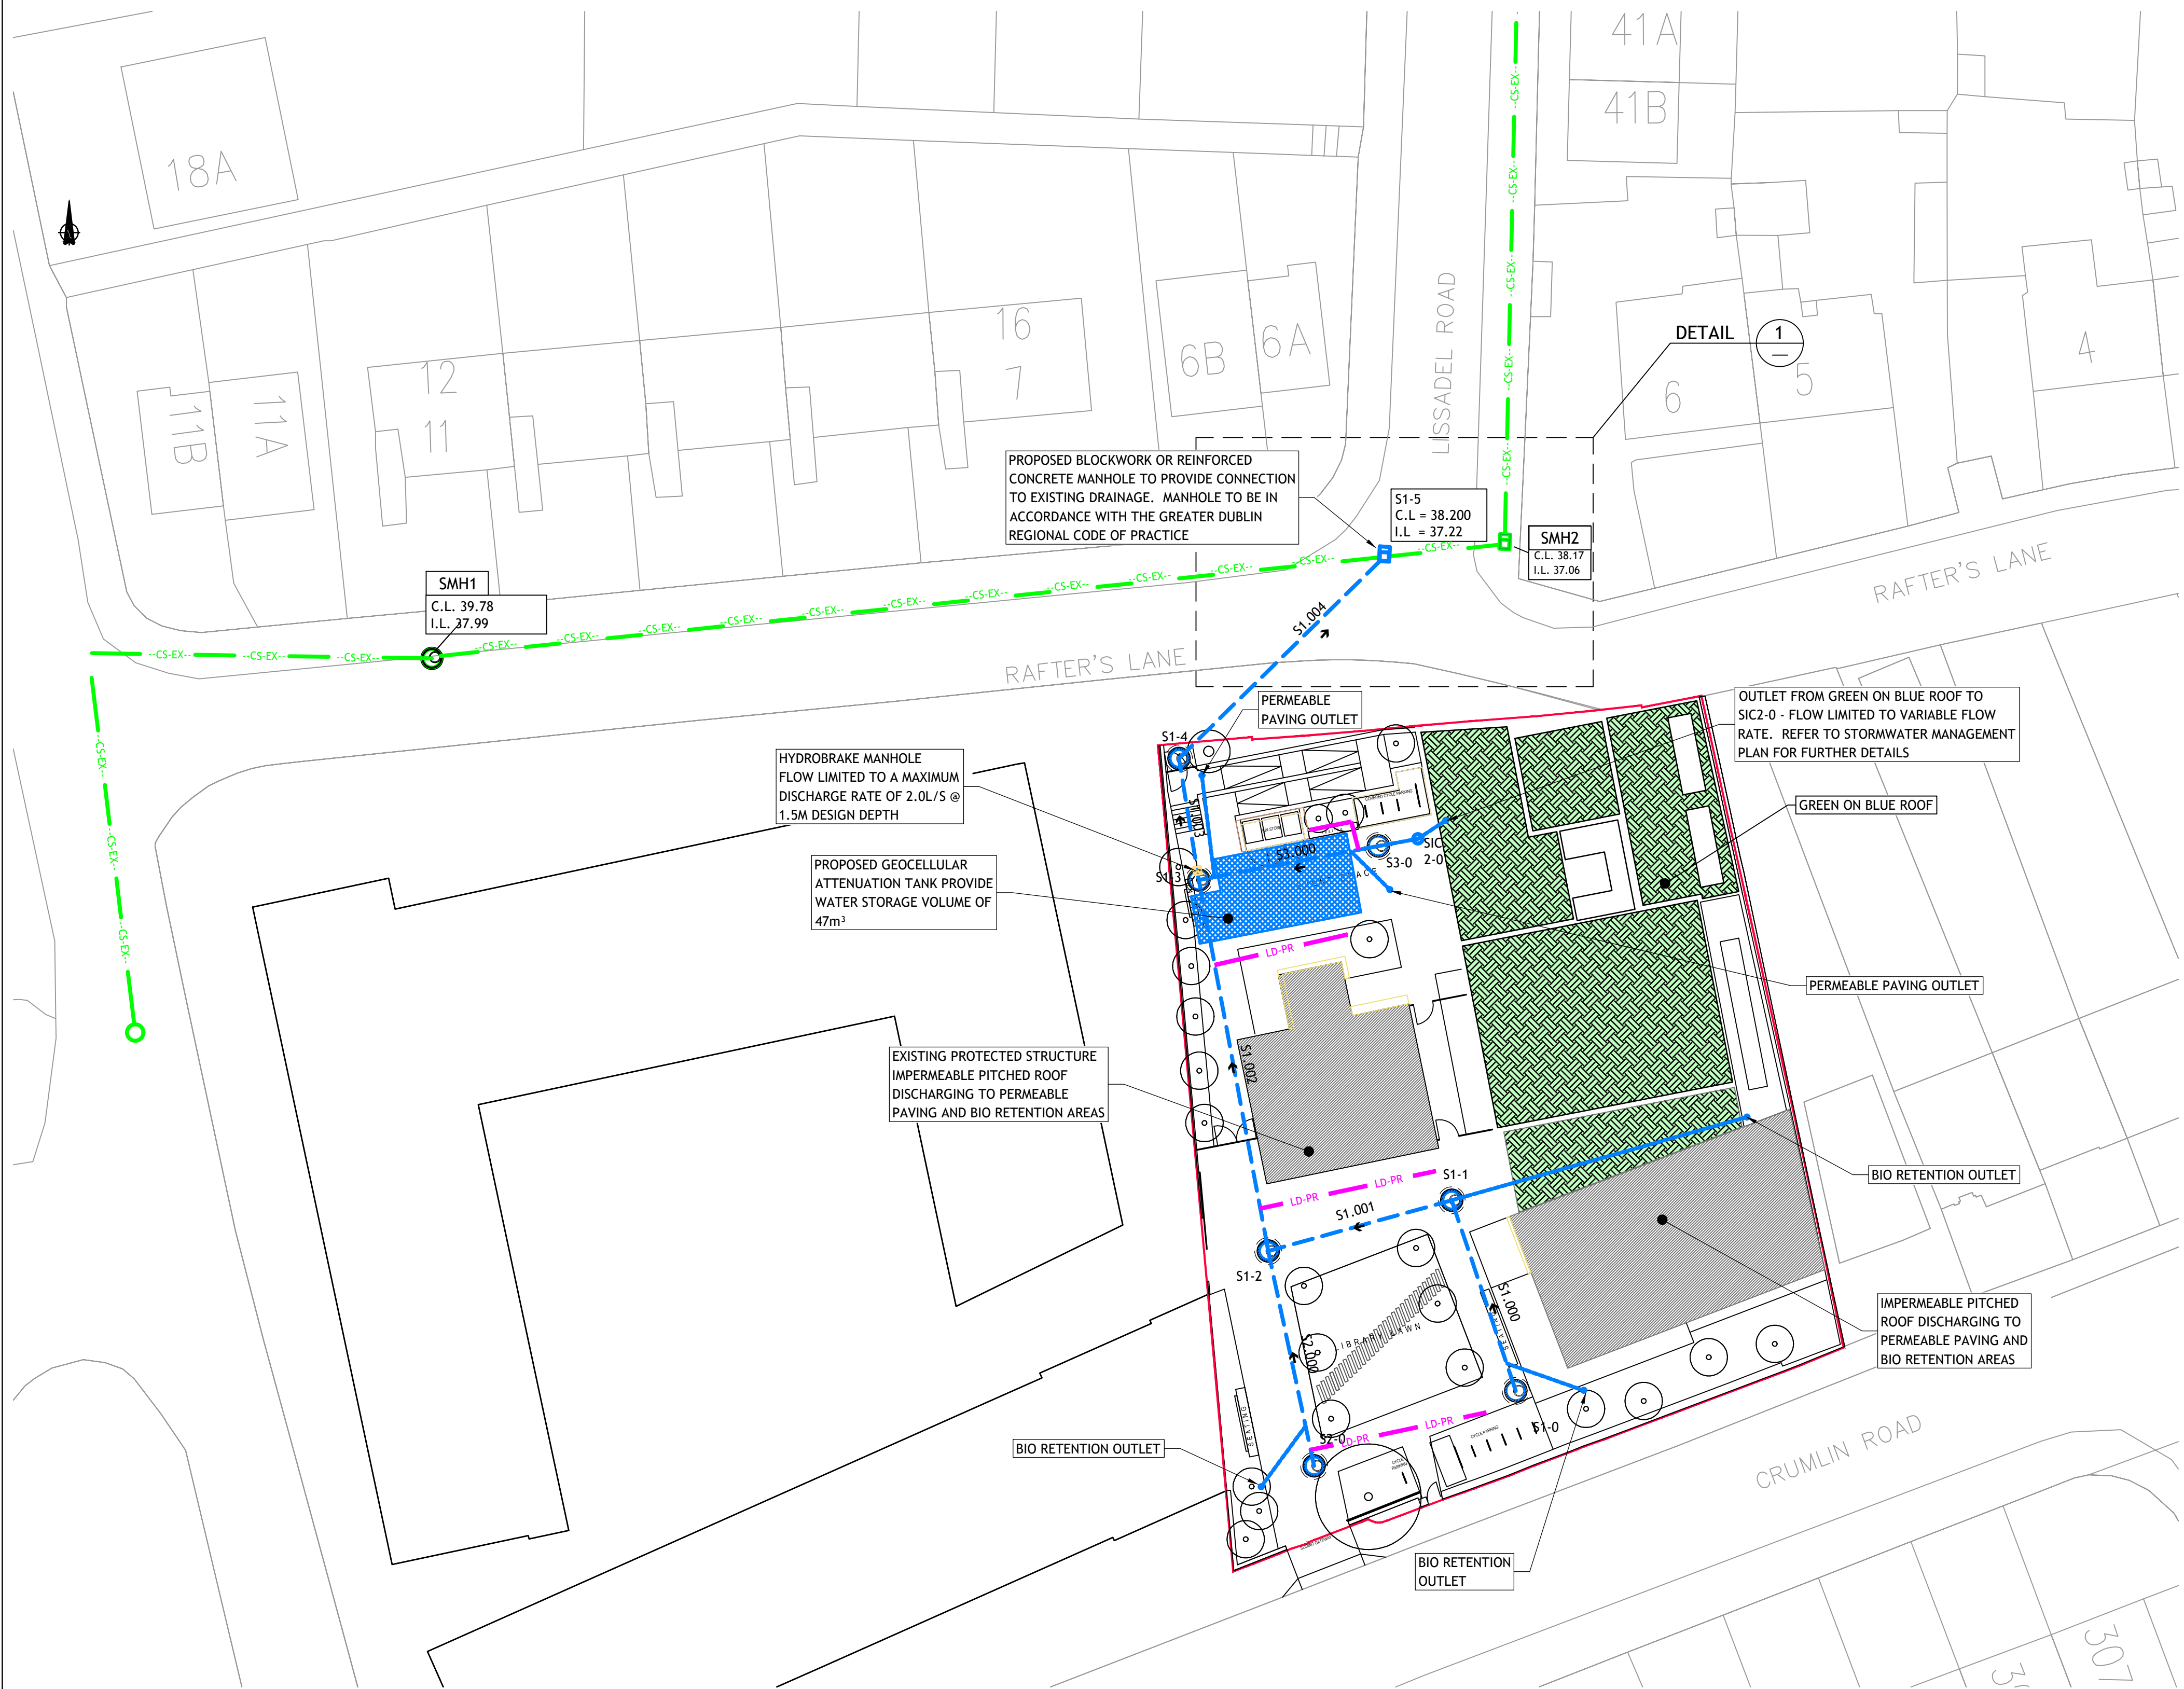

Ordnance Survey Ireland Licence No. CYAL50313286
© Ordnance Survey Ireland/Government of Ireland

© PUNCH Consulting Engineers

This drawing and any design hereon is the copyright of the Consultants and must not be reproduced without their written consent.
All drawings remain the property of the Consultants.
Figured dimension only to be taken from this drawing.
Consultants to be informed immediately of any discrepancies before work proceeds.

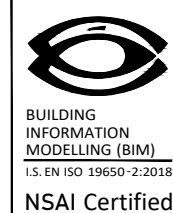

Rev	Amendment	By	Date
P01	PART 8 PLANNING	PF	14-06-2023
P02	SITE LAYOUT UPDATED	PF	20-06-2023
P03	GENERAL AMENDMENTS	PF	28-06-2023
P04	ARCHITECTS LAYOUT REV G UPDATED AND DETAIL 1 ADDED	PF	03-11-2023
P05	MINOR AMENDMENTS TO DRAINAGE & ATTENUATION TANK	PF	30-11-2023
C01	PART 8 PLANNING	PF	01-12-2023

Rev	Amendment	By	Date

Client:



Comhairle Cathrach
Bhaile Átha Cliath
Dublin City Council



Dublin | Limerick | Cork | Galway | Glasgow
Carnegie House Library Road,
Dun Laoghaire, Co. Dublin, A96 C7W7
t +353 1 271 2200 | w punchconsulting.com

Project: NEW LIBRARY CRUMLIN ROAD			
Title: SURFACE WATER DRAINAGE LAYOUT			
Drawn: PF	Date drawn: 2023-06-06	Technician Check: NH	Engineer Check: DT
Approved: LB			
Project No: 232168	Model Ref: 232168-PUNCH-XX-XX-MZ-0125	Drawing Status: A0	
Scale: 1:250	Doc No: 232168-PUNCH-XX-XX-DR-C-0125	Revision: C01	